

CALL BEFORE YOU DIG!
 PENNSYLVANIA LAW REQUIRES
 3 WORKING DAYS NOTICE FOR
 CONSTRUCTION PHASE AND 10 WORKING
 DAYS IN DESIGN STAGE - STOP, CALL
 PA SYSTEM, INC.
 CALL 1-800-242-1776
 OR DIA. 611

Boles, Smyth Associates Inc.
 Consulting Civil Engineers
 2400 Chestnut Street - Philadelphia PA, 19103
 215-561-2644 (P) - 215-561-0501 (F)

TIMOTHY F. BOLES
 ENGINEER


PROJECT
HENKELS & McCOY
Building Addition
 985 JOLLY ROAD
 BLUE BELL, PA 19422

PERMIT PLANS
 MAY 1, 2013

SHEET TITLE
PROPOSED SITE PLAN

REV	DATE	PURPOSE

DRAWING NUMBER
C-2

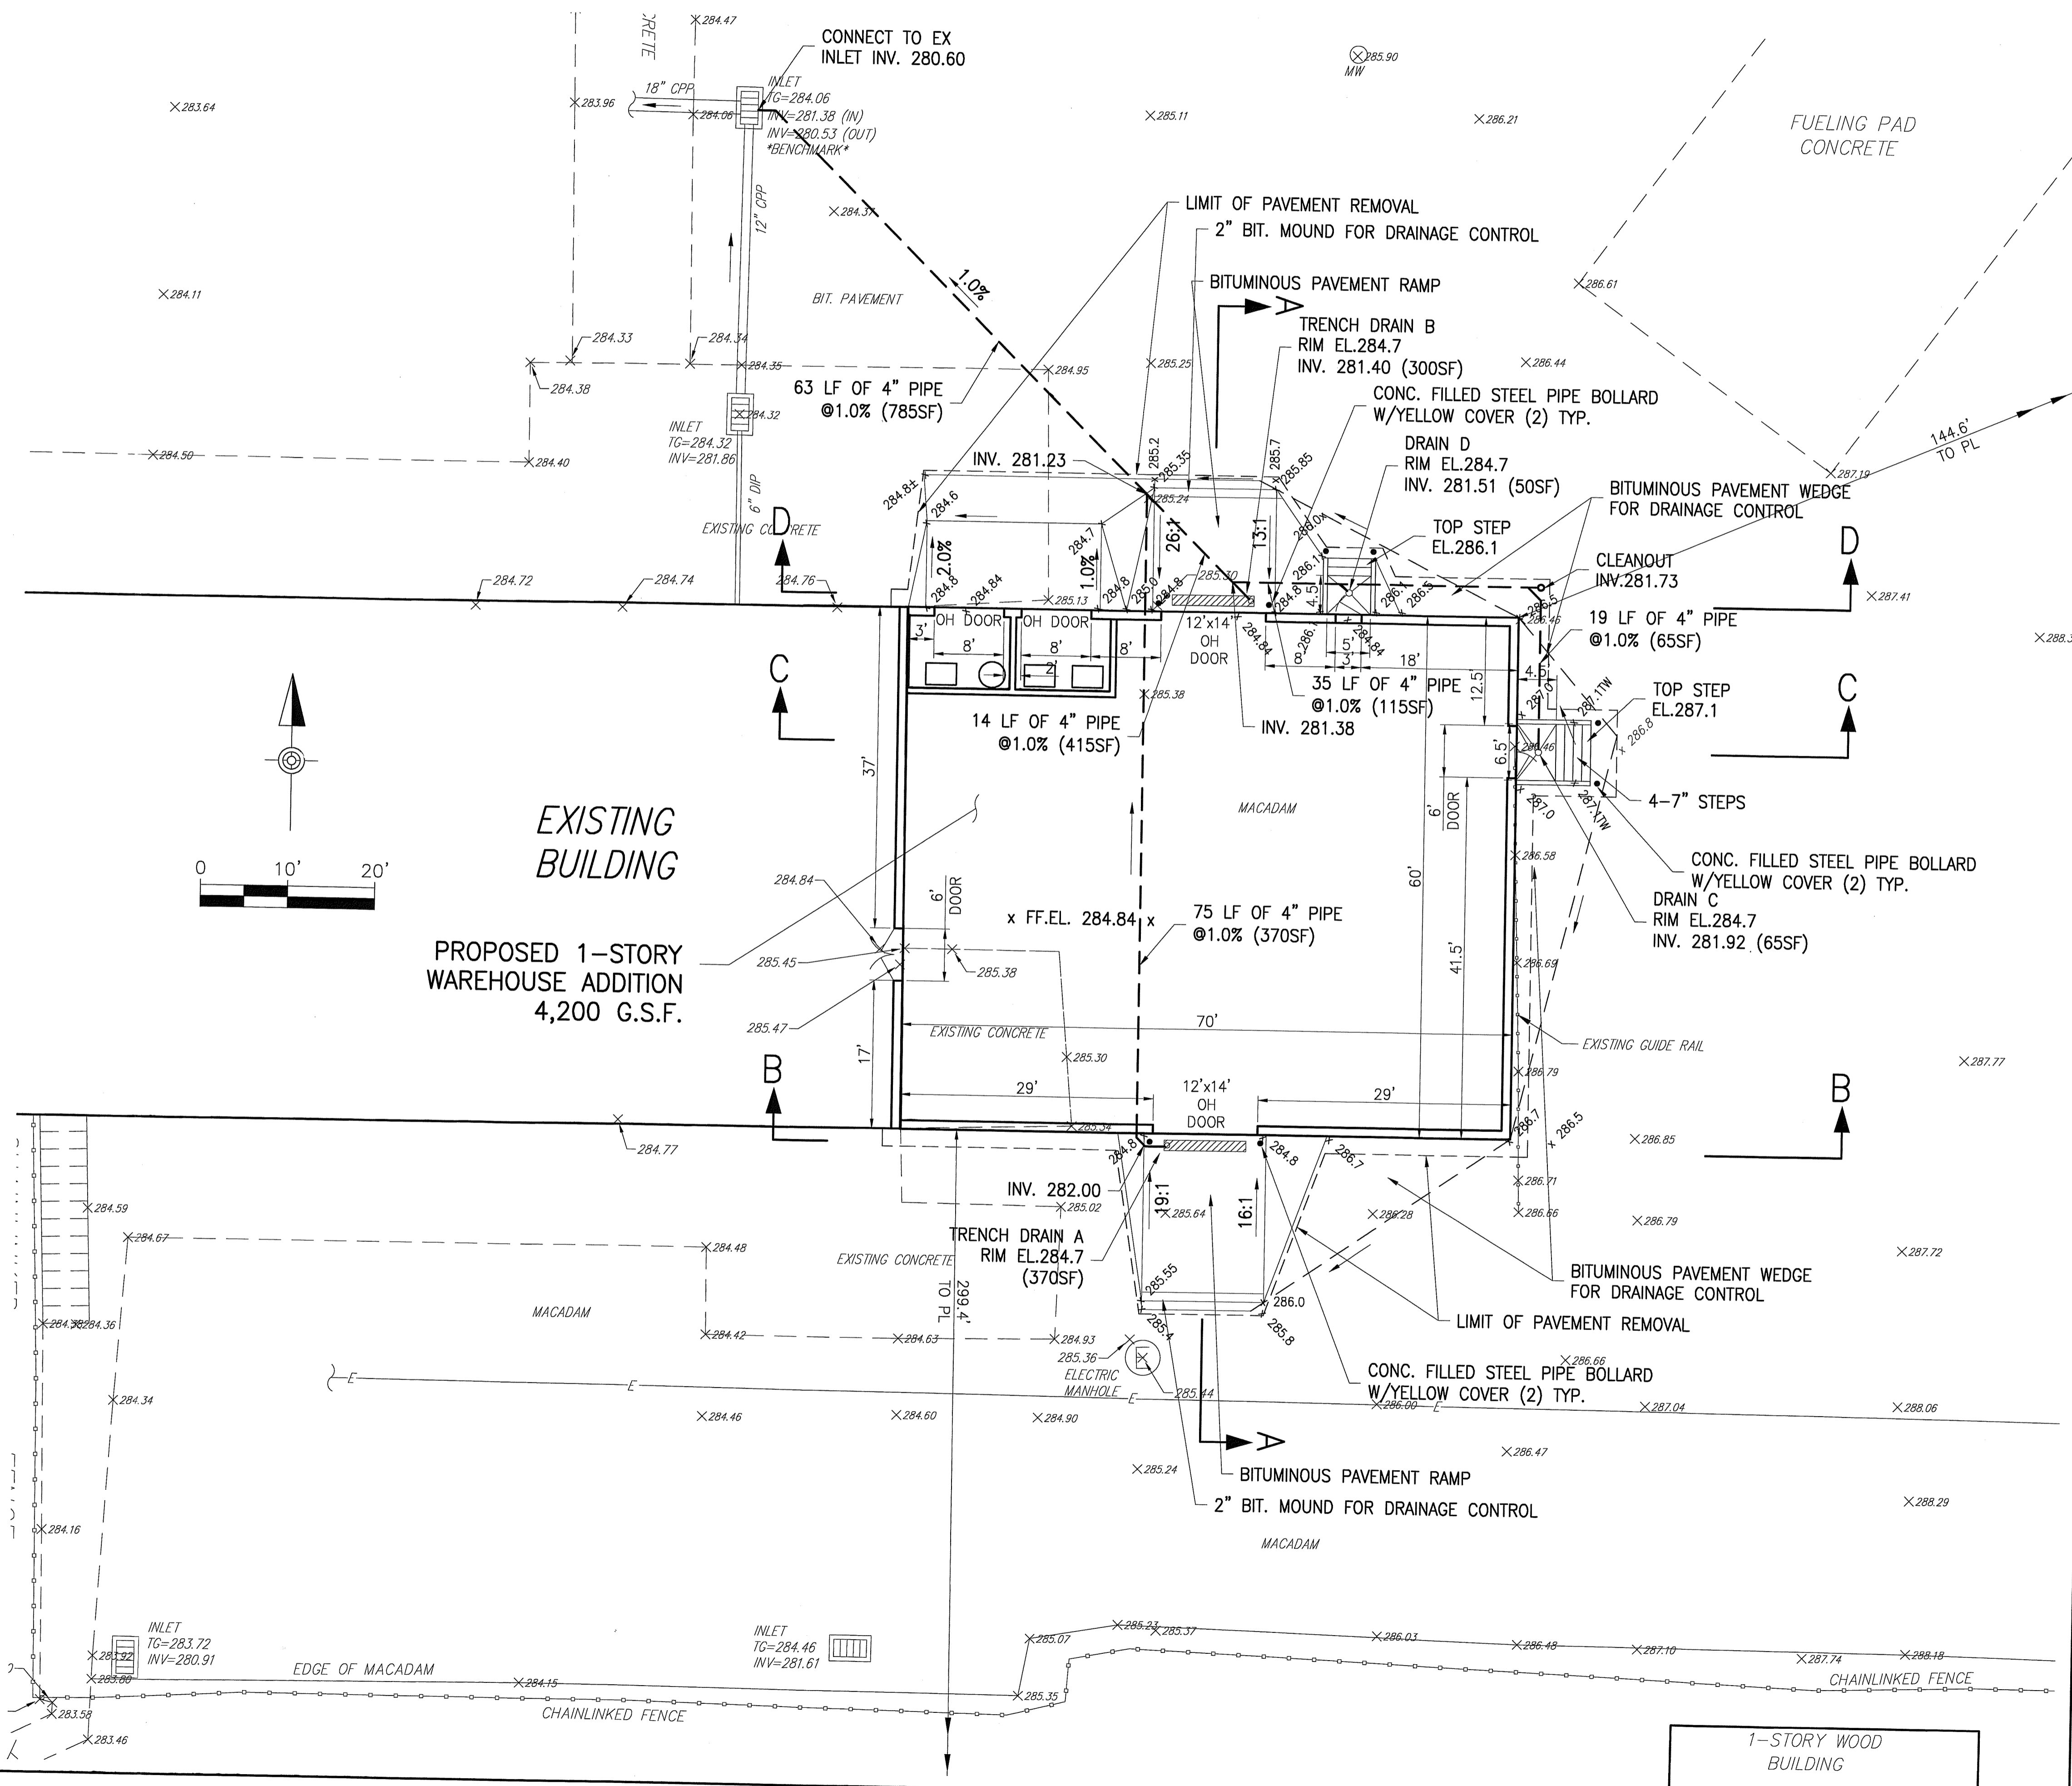

LEGEND

- x 286.8 EXISTING SOPT ELEVATION
- x 287.0 PROPOSED SPOT ELEVATION
- - - PAVEMENT REMOVAL LIMIT
- - - PROPOSED STORM DRAIN
- PROPOSED BOLLARD